

# QUICK RESPONSE EMERGENCY CALL BOX

CHEYENNE CAMPUS

3200 E. CHEYENNE AVE., NORTH LAS VEGAS, NEVADA 89030

STATE PUBLIC WORKS DIVISION ANNUAL PERMIT #12-B903

## BASIS OF DESIGN

BUILDING CODE EDITION:	2006 IBC 2006 UMC 2006 IFC 2009 IECC 2009 NEC	MAXIMUM HEIGHT: ZONING: SET BACKS: INSULATION PROVIDED: ALLOWABLE LIVE LOAD FOR ROOF AND FLOORS: SEISMIC ZONE: WIND SPEED AND EXPOSURE: ALLOWABLE SOIL BEARING PRESSURE: DESIGN STRESSES FOR BUILDING MATERIALS:	N/A (EXISTING) N/A (EXISTING) N/A (EXISTING) N/A (EXISTING) N/A (EXISTING) N/A (EXISTING) N/A (EXISTING) N/A (EXISTING) N/A (EXISTING)
SITE AREA:	17 ACRES	ICC/ANSI A117.1-2003 & 1994 ADAAG	
FLOOR AREA:	N/A		
OCCUPANCY GROUPS:	N/A		
TYPE OF CONSTRUCTION:	N/A		
REQD AREA OR OCC. SEPARATIONS:	N/A		
FIRE SPRINKLER REQUIREMENTS:	PROVIDED		
ALARM SYSTEMS:	PROVIDED		

## PROJECT DESIGN TEAM


ARCHITECT: WILFRED LEWIS, JR.  
3200 EAST CHEYENNE AVE. (SZH)  
NORTH LAS VEGAS, NV 89030-4228  
Tel: (702) 651-4888 Fax: (702) 651-2675  
WILFRED.LEWIS@CSN.EDU

## DRAWING LIST

TITLE SHEET	A0.01
SECURITY SITE PLAN	C1.01
SECURITY SITE DETAILS	C1.02

## GENERAL NOTES


- EXISTING BUILDING TO REMAIN IN OPERATION DURING CONSTRUCTION. MAINTAIN SITE CLEAN AND FREE OF DEBRIS DURING CONSTRUCTION. MAINTAIN ALL EGRESS ROUTES. DO NOT BLOCK EXITS. NOTIFY CSN FACILITIES MANAGEMENT (CONSTRUCTION MANAGEMENT) IF ANY UTILITY SERVICE IS TO BE INTERRUPTED.
- ALL SITE-RELATED WORK TO BE CONSTRUCTED TO MEET SPWD UNIFORM STANDARD DRAWINGS AND SPECIFICATIONS.
- CONTRACTOR TO INSPECT ALL EXISTING CONDITIONS AND NOTIFY CSN FACILITIES MANAGEMENT (CONSTRUCTION MANAGER) OF ANY DISCREPANCIES PRIOR TO CONSTRUCTION.
- ALL INTERIOR WALL & CEILING FINISHES TO COMPLY WITH CLASS "C" RATING FOR ROOMS, ENCLOSED SPACES, AND CORRIDORS (IBC SECTION 805.5). INTERIOR FLOOR FINISHES IN EXIT PASSAGEWAYS, CORRIDORS AND EXIT ENCLOSURES SHALL COMPLY WITH CLASS II RATING. FLOOR COVERING MATERIALS SHALL COMPLY WITH THE DOCF-1 "PILL TEST" (OPSC 16 CFR PART 1630) WHERE THERE IS ANY APPROVED AUTOMATIC SPRINKLER SYSTEM (IBC SECTION 804.4.1)

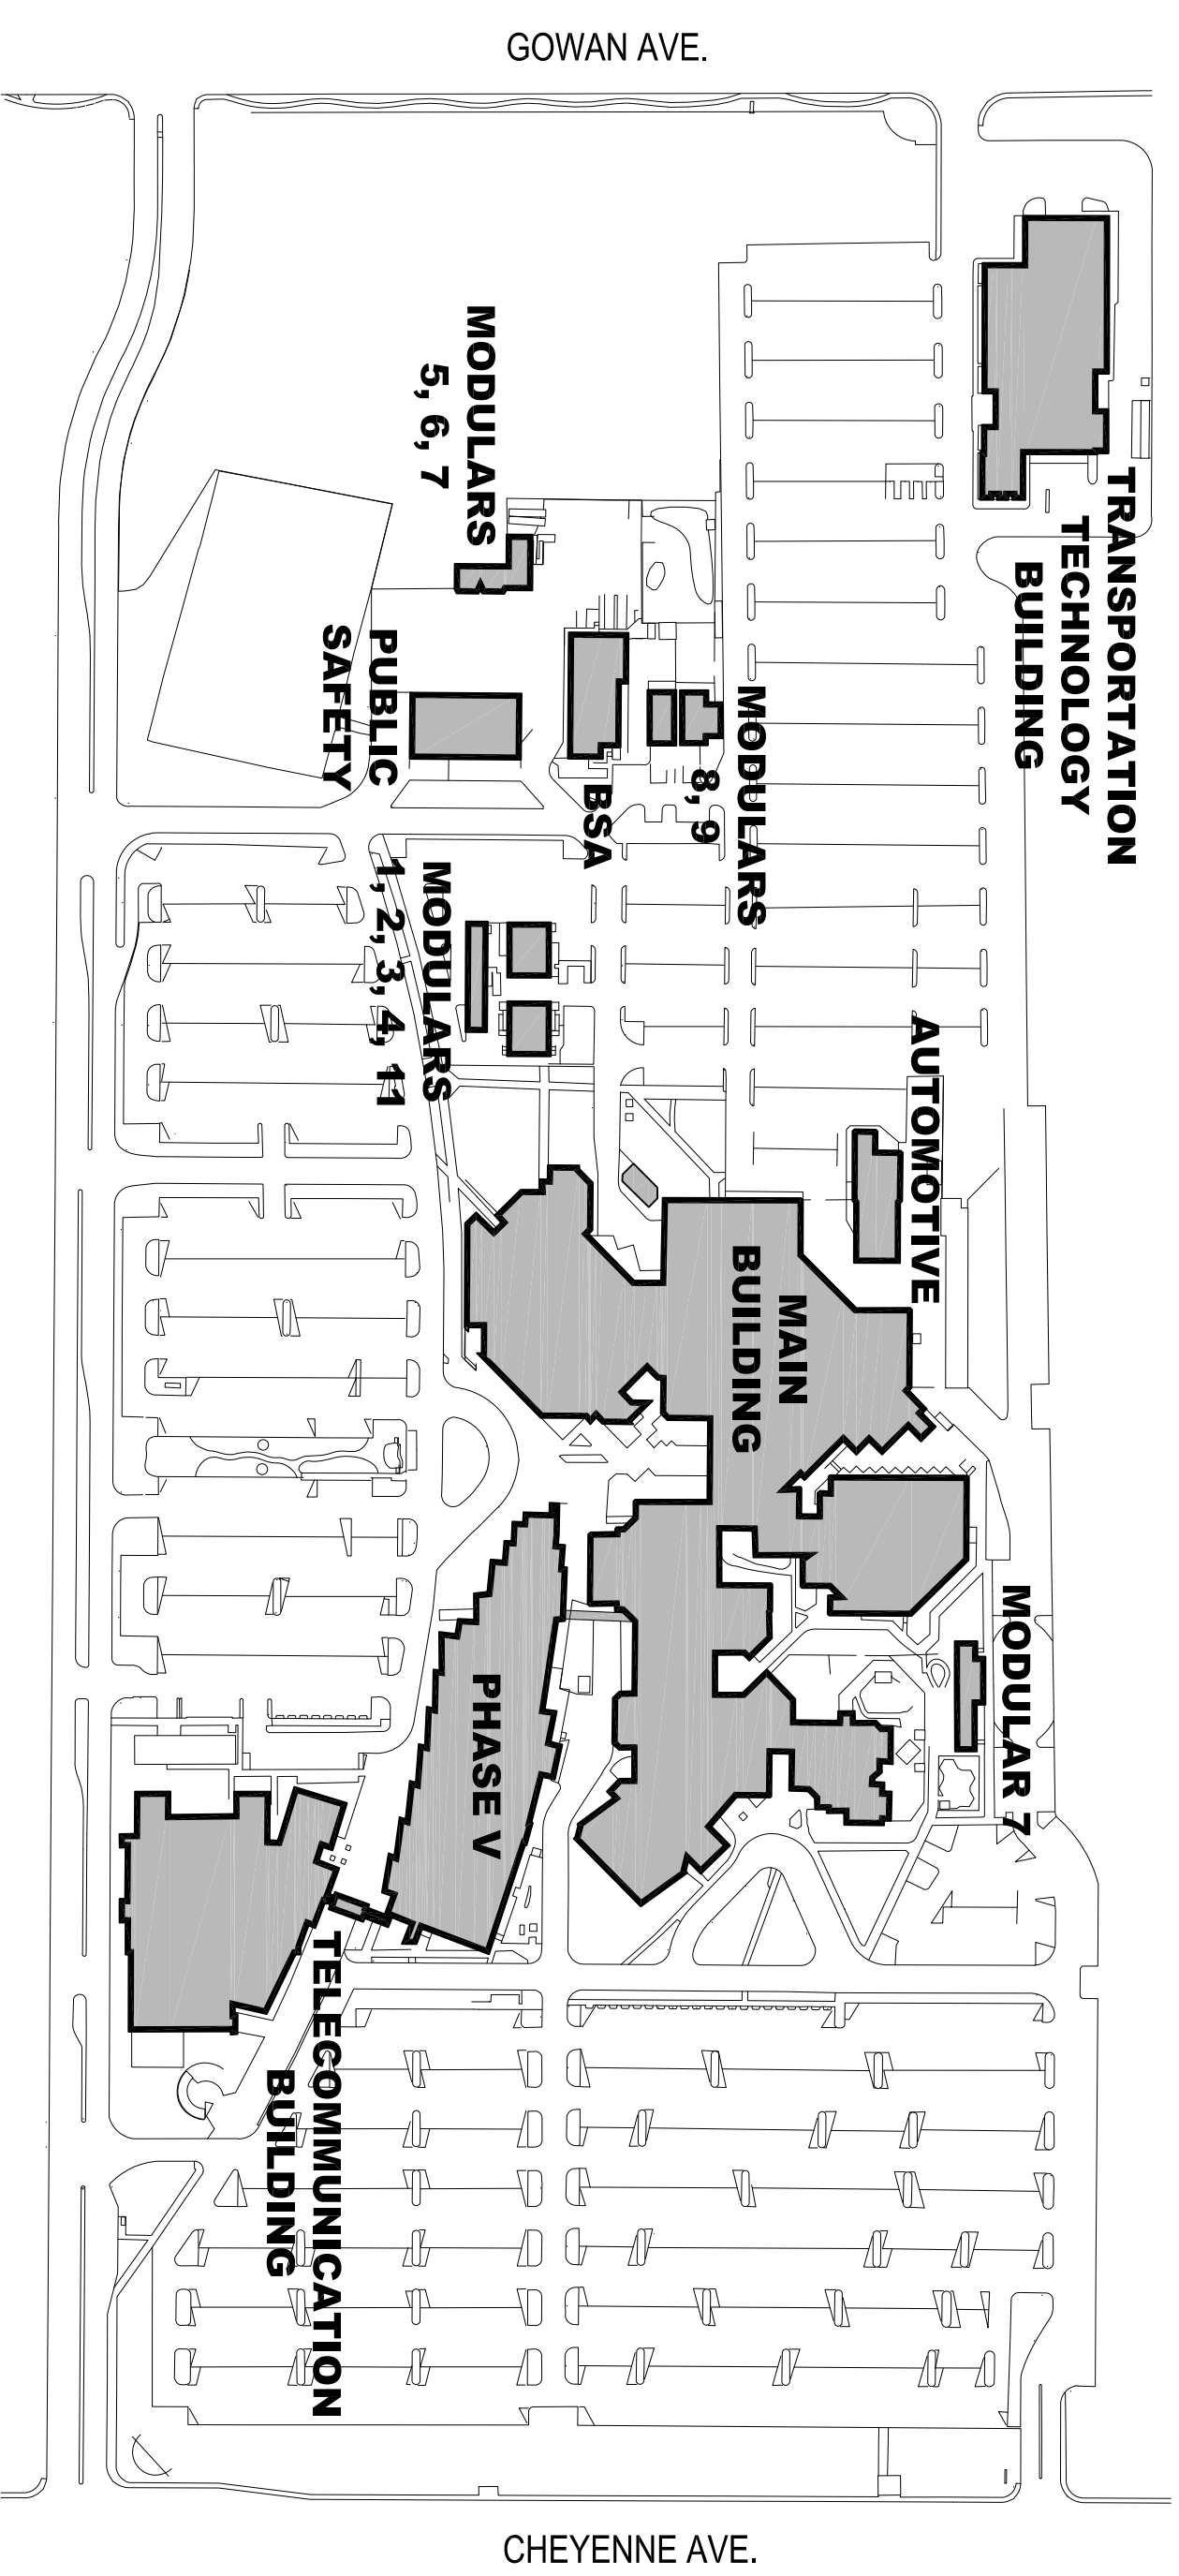

## SITE LOCATION MAP

SCALE = NONE

CHEYENNE SITE MAP

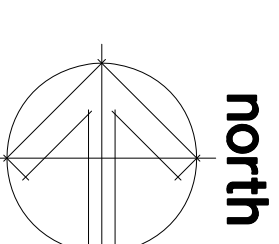

No.	Revision	Approved	Date

<b>Campus:</b> CHEYENNE
<b>Rm(s) Area:</b> SITE
<b>Project:</b> <b>QUICK RESPONSE EMERGENCY CALL BOX</b>



DEPARTMENT OF FACILITIES MANAGEMENT  
CHEYENNE CAMPUS  
3200 EAST CHEYENNE AVE.  
NORTH LAS VEGAS, NEVADA 89030  
PHONE: (702) 651-4888 FAX: (702) 651-2675

SEAL: \_\_\_\_\_  
These drawings are property of CSN and may not be reproduced or used in any way without the consent of CSN.

**Job #:** CC-11045A  
**Dwg. Name:** A0.01-TITLE  
**Drawn:** WSS  
**Date:** 11/21/11  
**Scale:** VARIES

**Sheet Title:**  
**TITLE SHEET**  
**Sheet:**  
**A0.01**