

QUICK RESPONSE EMERGENCY CALL BOX

WEST CHARLESTON CAMPUS,
6375 WEST CHARLESTON BLVD., LAS VEGAS, NEVADA 89146

STATE PUBLIC WORKS DIVISION ANNUAL PERMIT #12-B903

BASIS OF DESIGN

BUILDING CODE EDITION:	2006 IBC 2006 UMC 2006 IFC 2009 IECC 2009 NEC ICC/ANSI A117.1-2003 & 1994 ADAAG 17 ACES	MAXIMUM HEIGHT:	N/A (EXISTING)
ZONING:			N/A (EXISTING)
SET BACKS:			N/A (EXISTING)
INSULATION PROVIDED:			N/A (EXISTING)
ALLOWABLE LIVE LOAD FOR ROOF AND FLOORS:			N/A (EXISTING)
SEISMIC ZONE:			N/A (EXISTING)
WIND SPEED AND EXPOSURE:			N/A (EXISTING)
ALLOWABLE SOIL BEARING PRESSURE:			N/A (EXISTING)
DESIGN STRESSES FOR BUILDING MATERIALS:			N/A (EXISTING)
FLOOR AREA:			
OCCUPANCY GROUPS:			
TYPE OF CONSTRUCTION:			
REG'D AREA OR OCC. SEPARATIONS:			
FIRE SPRINKLER REQUIREMENTS:			
ALARM SYSTEMS:			

PROJECT DESIGN TEAM


ARCHITECT: WILFRED LEWIS, JR
3200 EAST CHEYENNE AVE. (S2H)
NORTH LAS VEGAS, NV 89030-4228
Tel (702) 651-4888 Fax (702) 651-2675
WILFRED.LEWIS@CSN.NEVADO

DRAWING LIST

TITLE SHEET	A0.01
SECURITY SITE PLAN	C1.01
SECURITY SITE DETAILS	C1.02

GENERAL NOTES


- EXISTING BUILDING TO REMAIN IN OPERATION DURING CONSTRUCTION. MAINTAIN SITE CLEAN AND FREE OF DEBRIS DURING CONSTRUCTION. MAINTAIN ALL EGRESS ROUTES. DO NOT BLOCK EXITS. NOTIFY CSN FACILITIES MANAGEMENT (CONSTRUCTION MANAGER) IF ANY UTILITY SERVICE IS TO BE INTERRUPTED.
- ALL SITE-RELATED WORK TO BE CONSTRUCTED TO MEET SPWID UNIFORM STANDARD DRAWINGS AND SPECIFICATIONS.
- CONTRACTOR TO INSPECT ALL EXISTING CONDITIONS AND NOTIFY CSN FACILITIES MANAGEMENT (CONSTRUCTION MANAGER) OF ANY DISCREPANCIES PRIOR TO CONSTRUCTION.
- ALL INTERIOR WALL & CEILING FINISHES TO COMPLY WITH CLASS 'C' RATING FOR ROOMS, ENCLOSED SPACES, AND CORRIDORS (IBC SECTION 805.5). INTERIOR FLOOR FINISHES IN EXIT PASSAGEWAYS, CORRIDORS AND EXIT ENCLOSURES SHALL COMPLY WITH CLASS II RATING. FLOOR COVERING MATERIALS SHALL COMPLY WITH THE DOCF-1 "PULL TEST" (CPSC 16 CFR, PART 1630) WHERE THERE IS ANY APPROVED AUTOMATIC SPRINKLER SYSTEM (IBC SECTION 804.4.1)

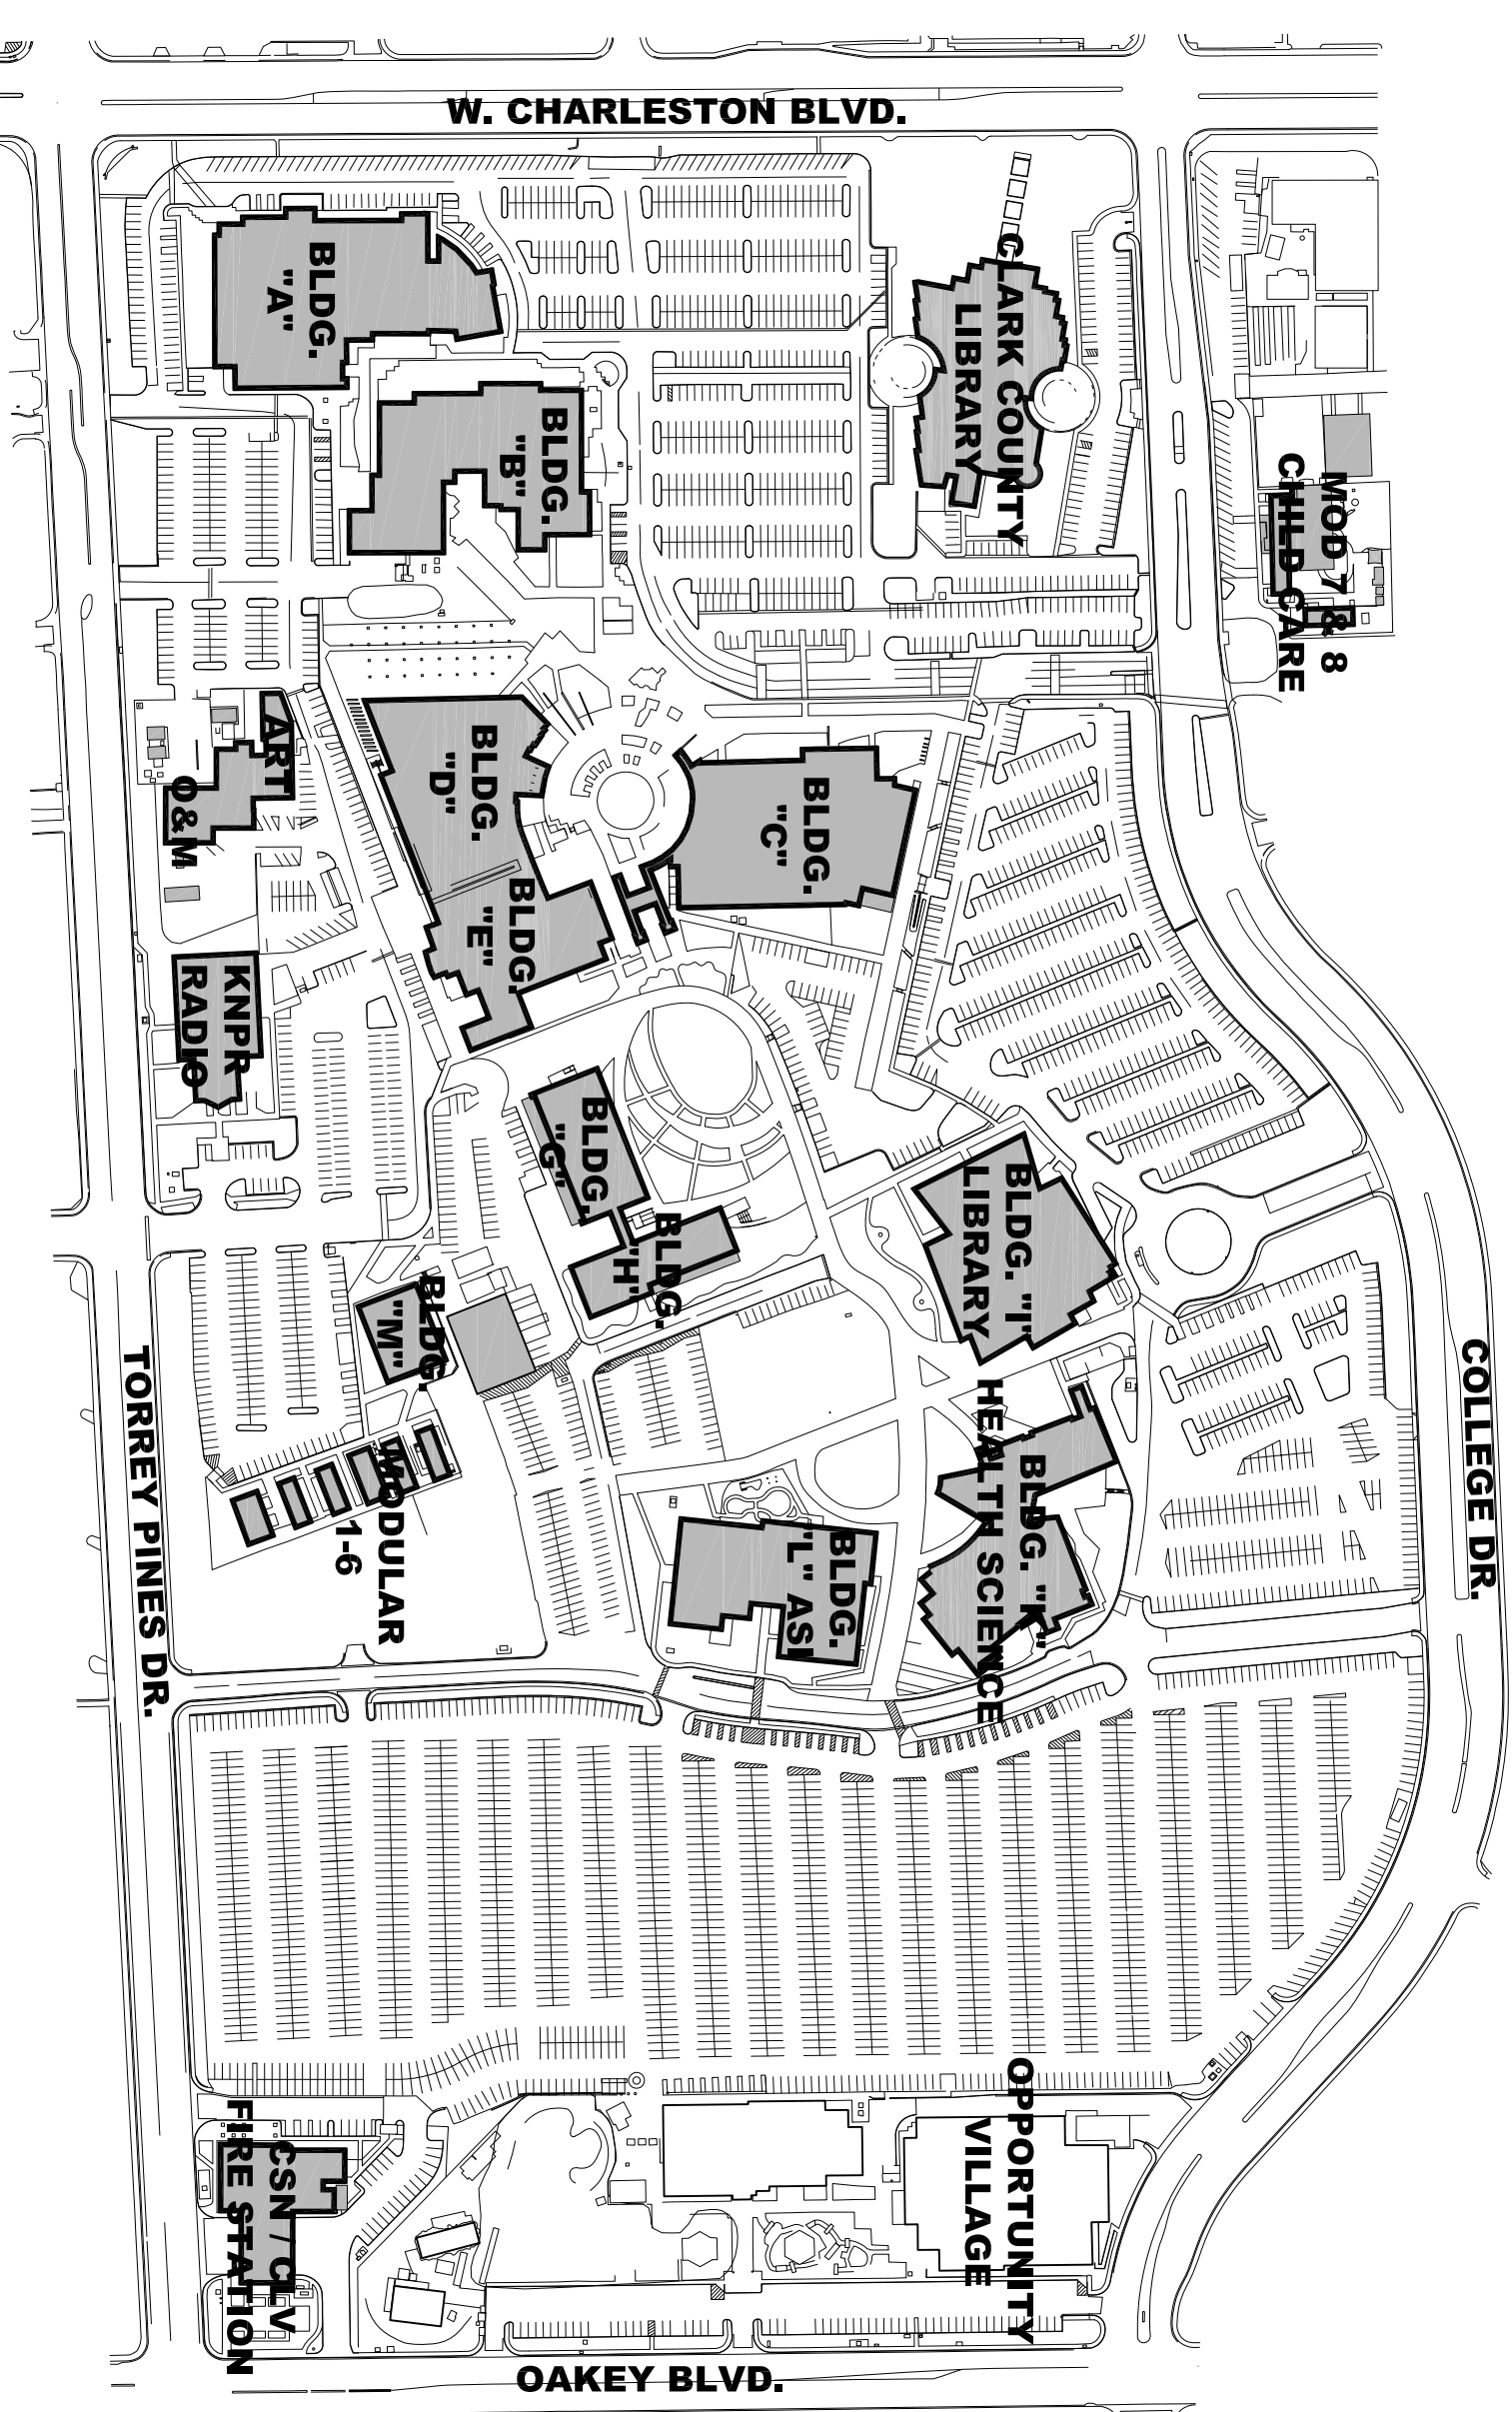

SITE LOCATION MAP

SCALE = NONE

WCC-Site Plan

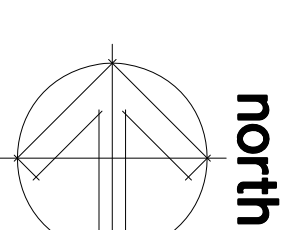

No:	Revision	Approved	Date

Campus: WEST CHARLESTON
Rm(s) Area: SITE
Project:
QUICK RESPONSE EMERGENCY CALL BOX



DEPARTMENT OF FACILITIES MANAGEMENT
CHEYENNE CAMPUS
3200 EAST CHEYENNE AVE. (S2H)
NORTH LAS VEGAS, NEVADA 89030
PHONE: (702) 651-4888 FAX: (702) 651-2675

SEAL:

These drawings are property of CSN and may not be reproduced or used without the written consent.

Job #: WCC-11045B
Dwg. Name: A0.01-TITLE
Drawn: WSS
Date: 11/21/11
Scale: VARIES

Sheet Title:
TITLE SHEET

Sheet:
A0.01